



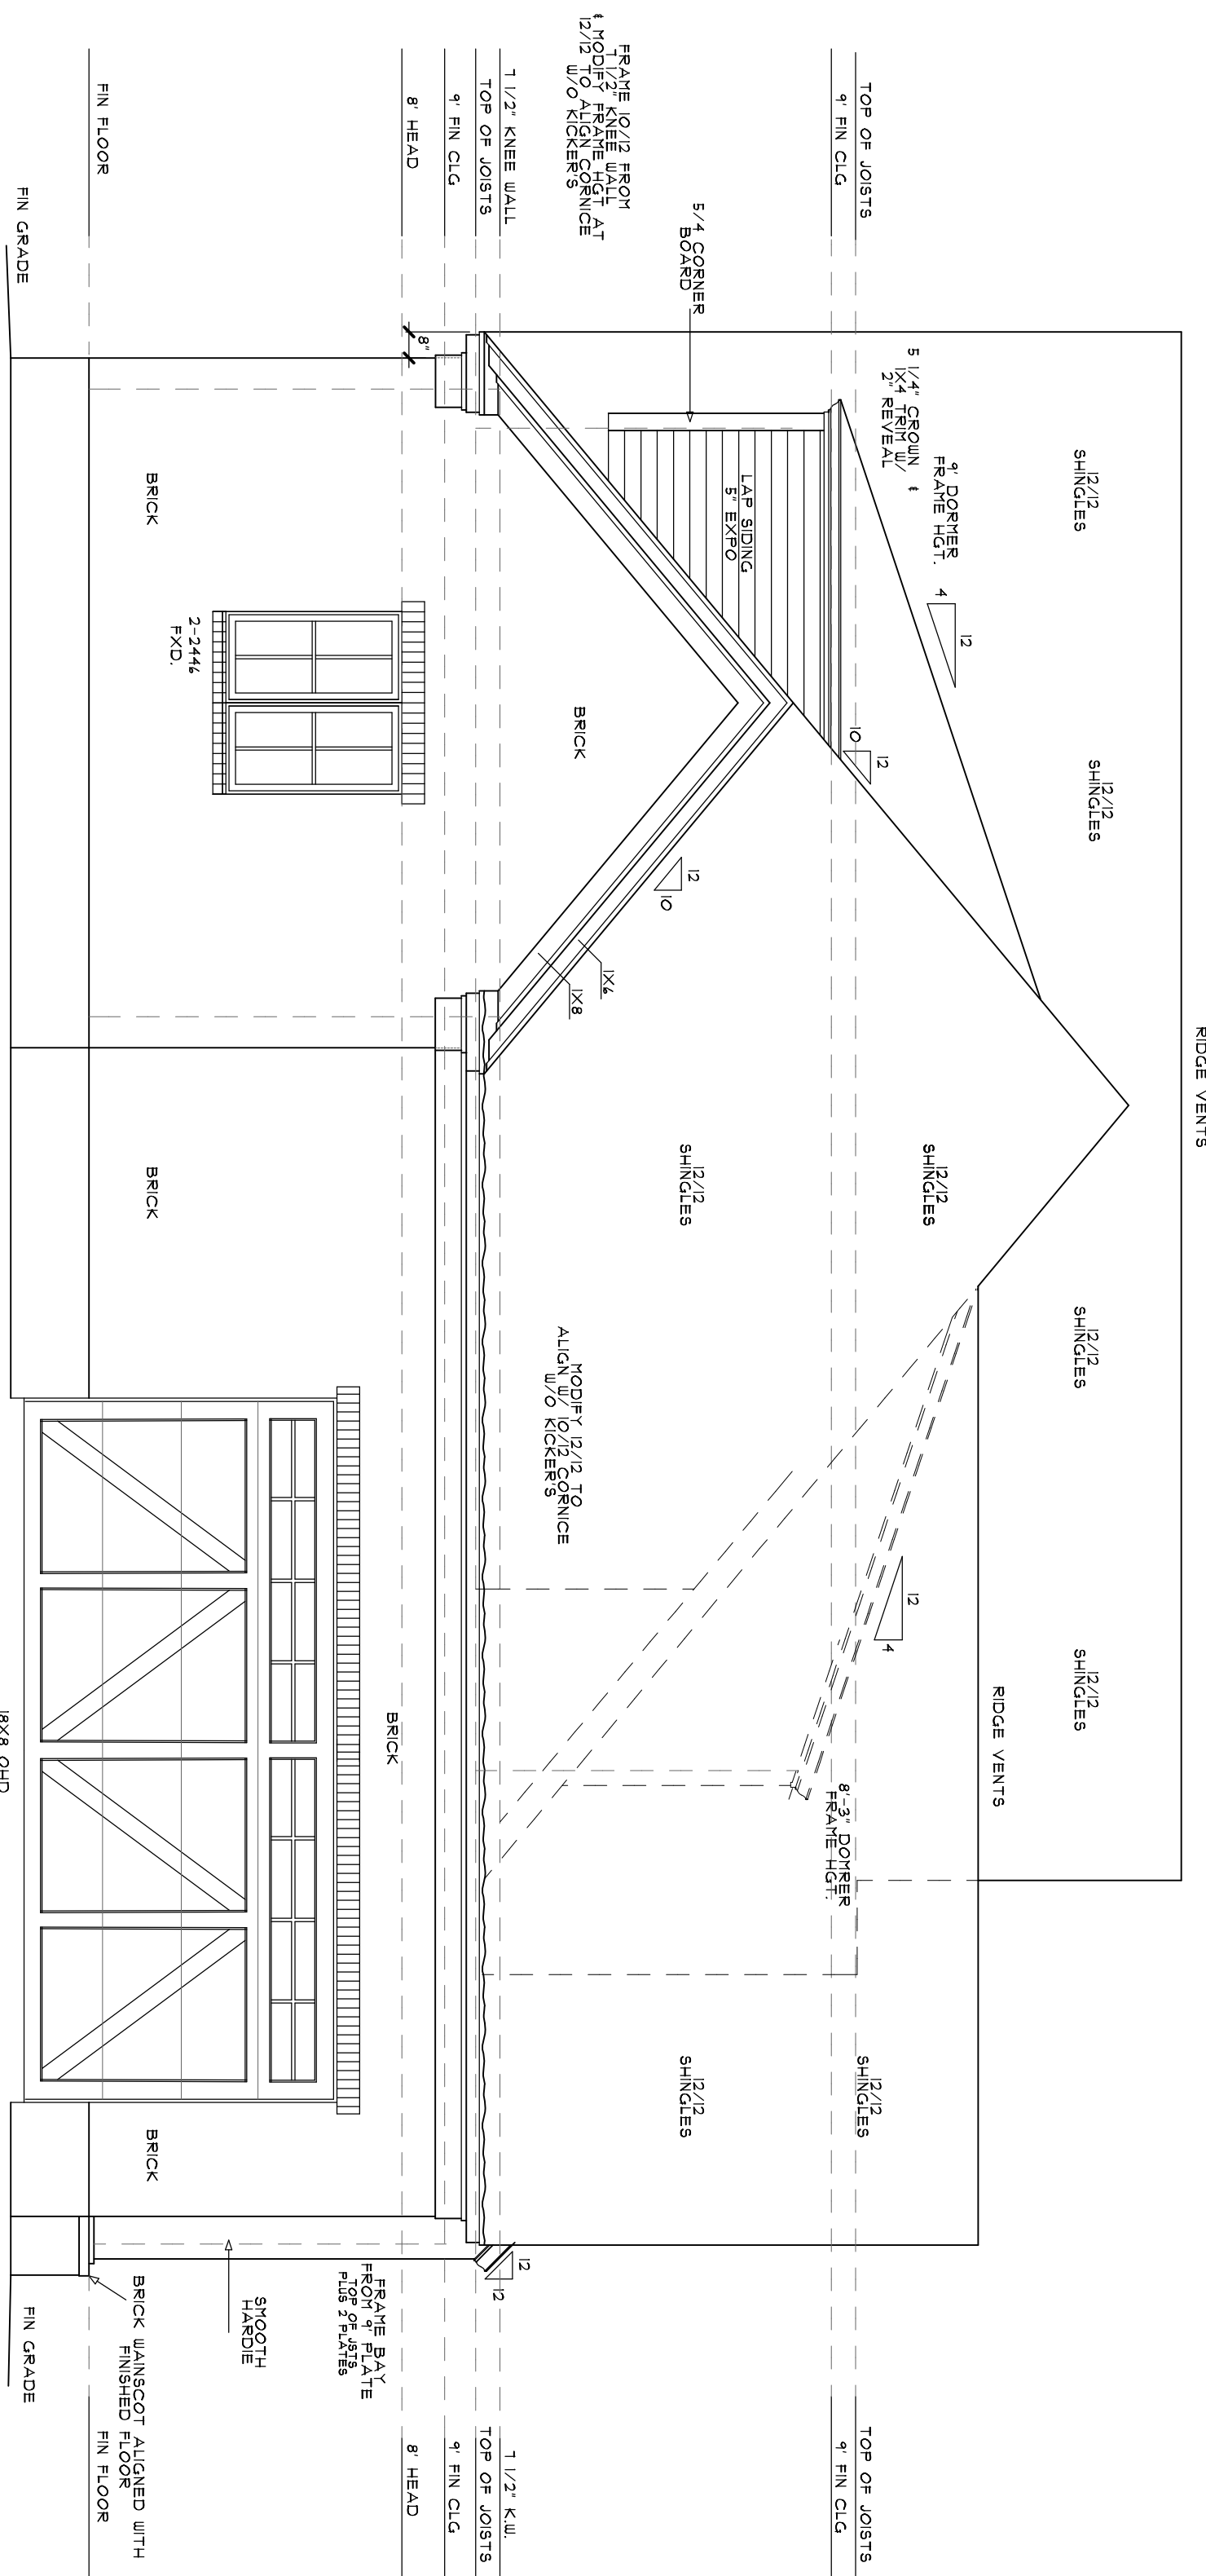

REAR ELEVATION

1/4"=1'-0"

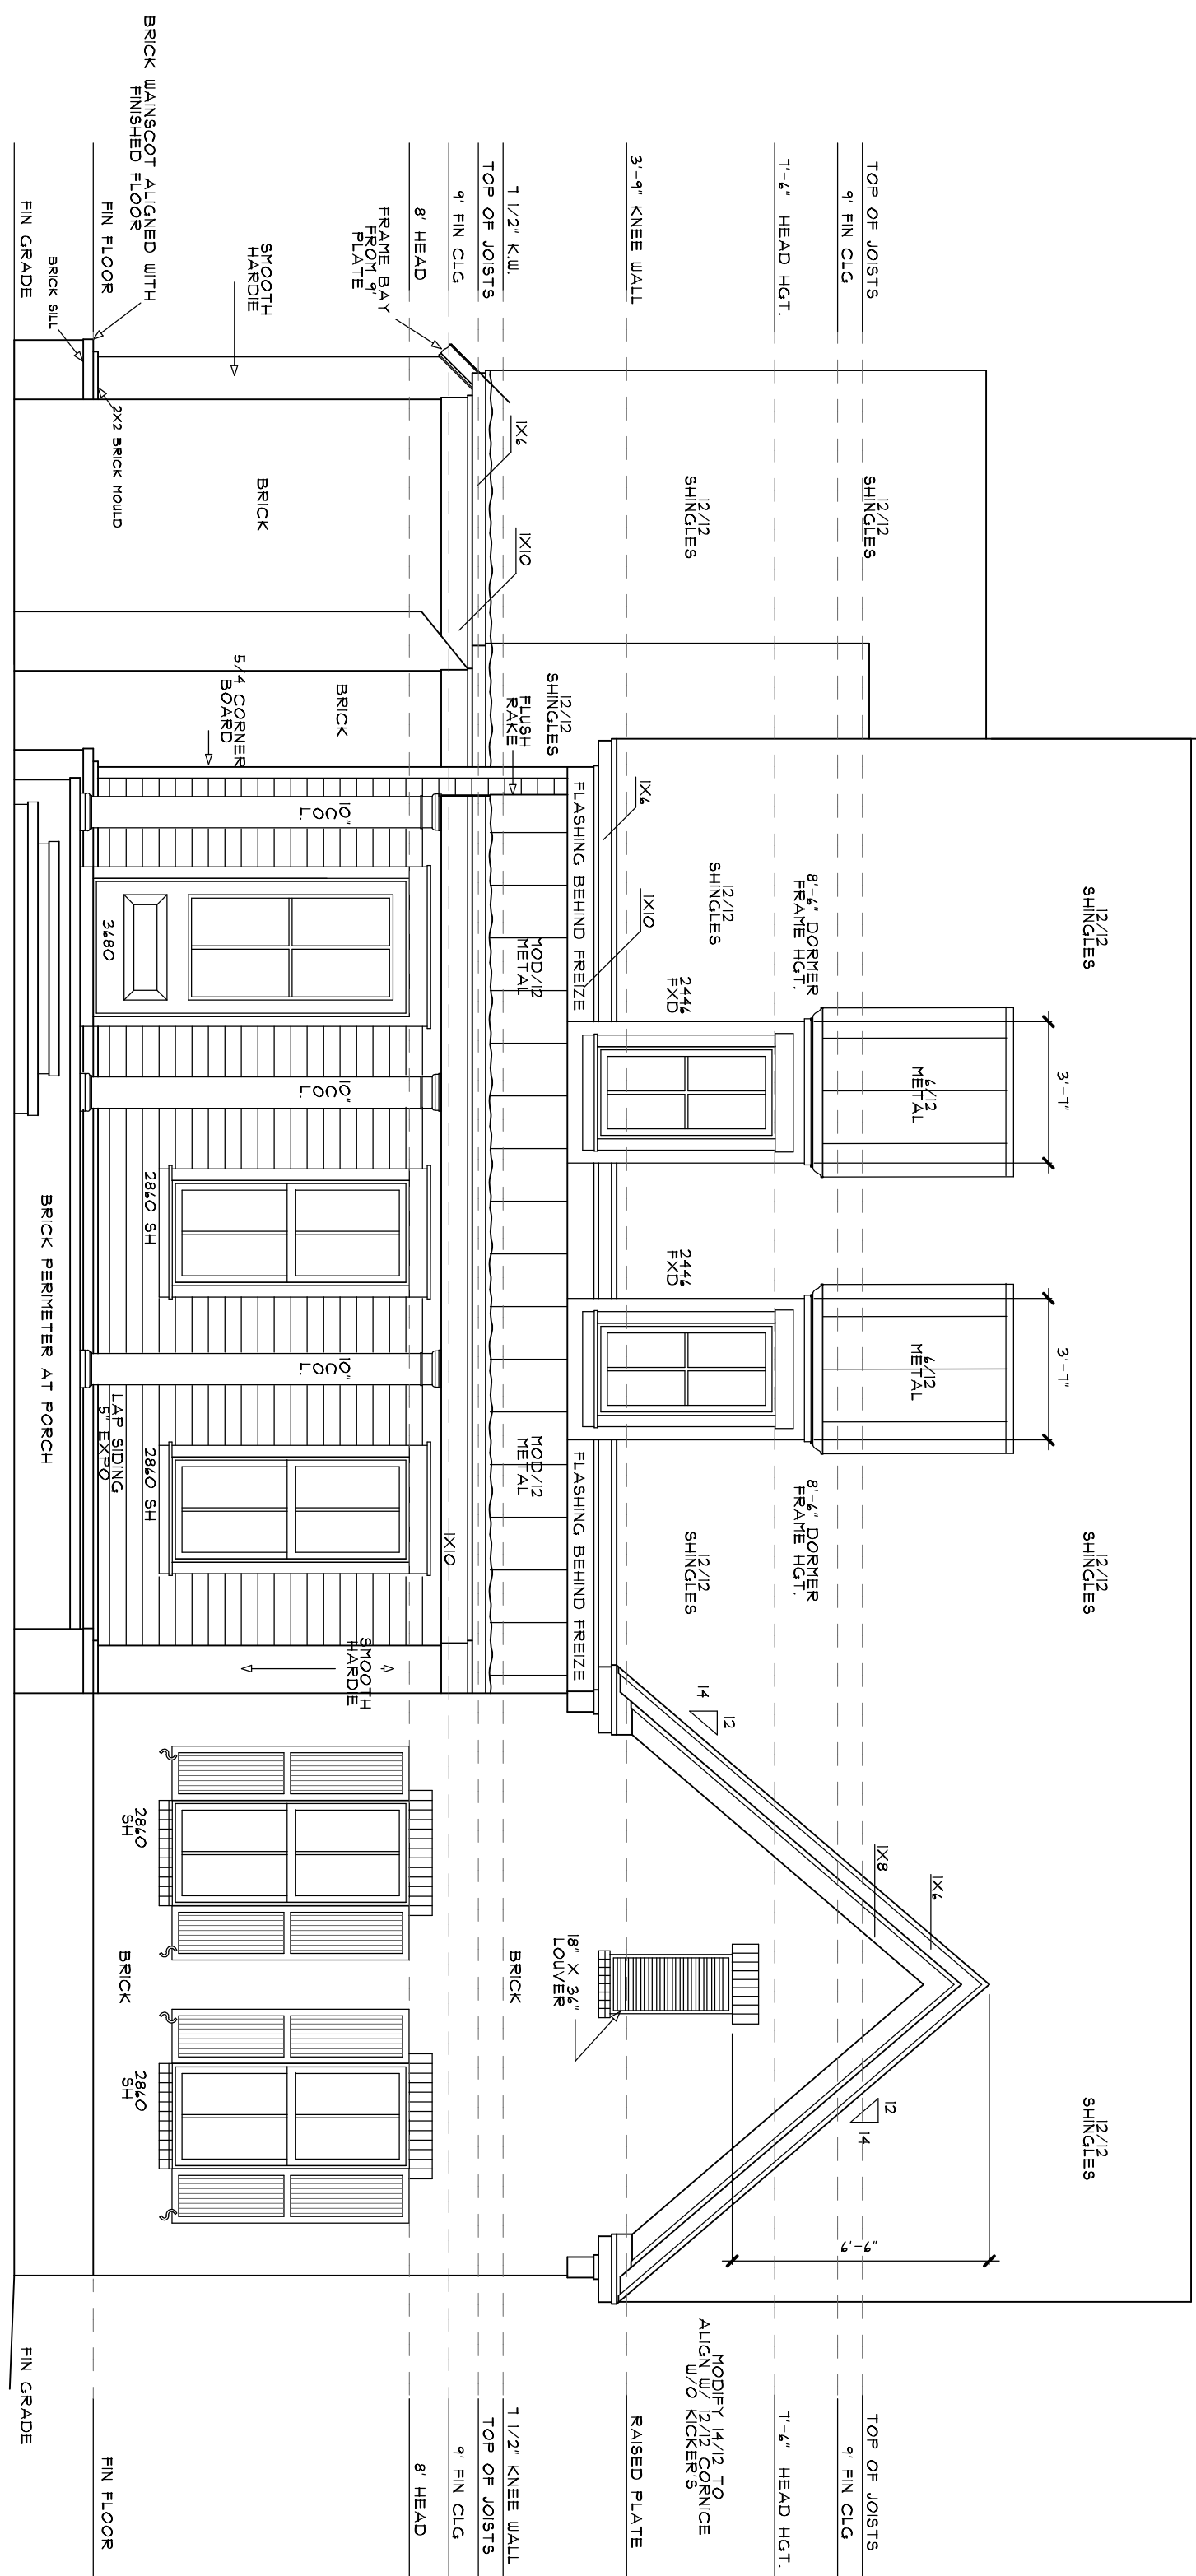


FRONT ELEVATION

1/4"=1'-0"


AREAS:	
HTD DN	2238 SQ. FT.
HTD UP	391 SQ. FT.
TOTAL HTD	2689 SQ. FT.
PORCH	428 SQ. FT.
CAR & STOR.	575 SQ. FT.

DRAWN :	CHECKED :
DATE : 8-03-2024	SCALE : AS NOTED
JOB NO. : PPH187	B805D RUCH
SHEET	

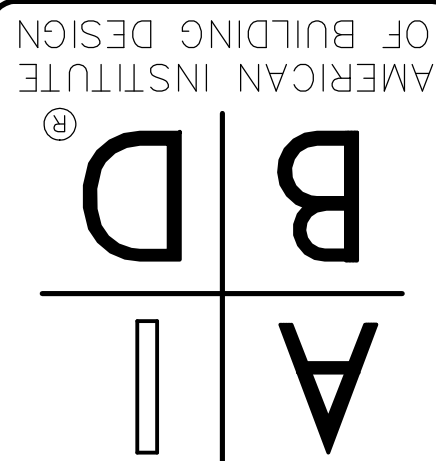


CLASSIC HOME DESIGNS

ED YENDREK AND ASSOCIATES
185 N MAIN ST. SUITE 101 38017
COLLIERVILLE, TENNESSEE
PHONE: 901-854-6900 FAX: 901-854-7170
WWW.CHDHOMED.COM

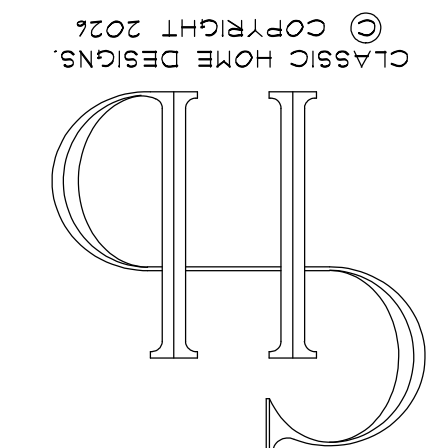

© COPYRIGHT 2024
CLASSIC HOME DESIGNS

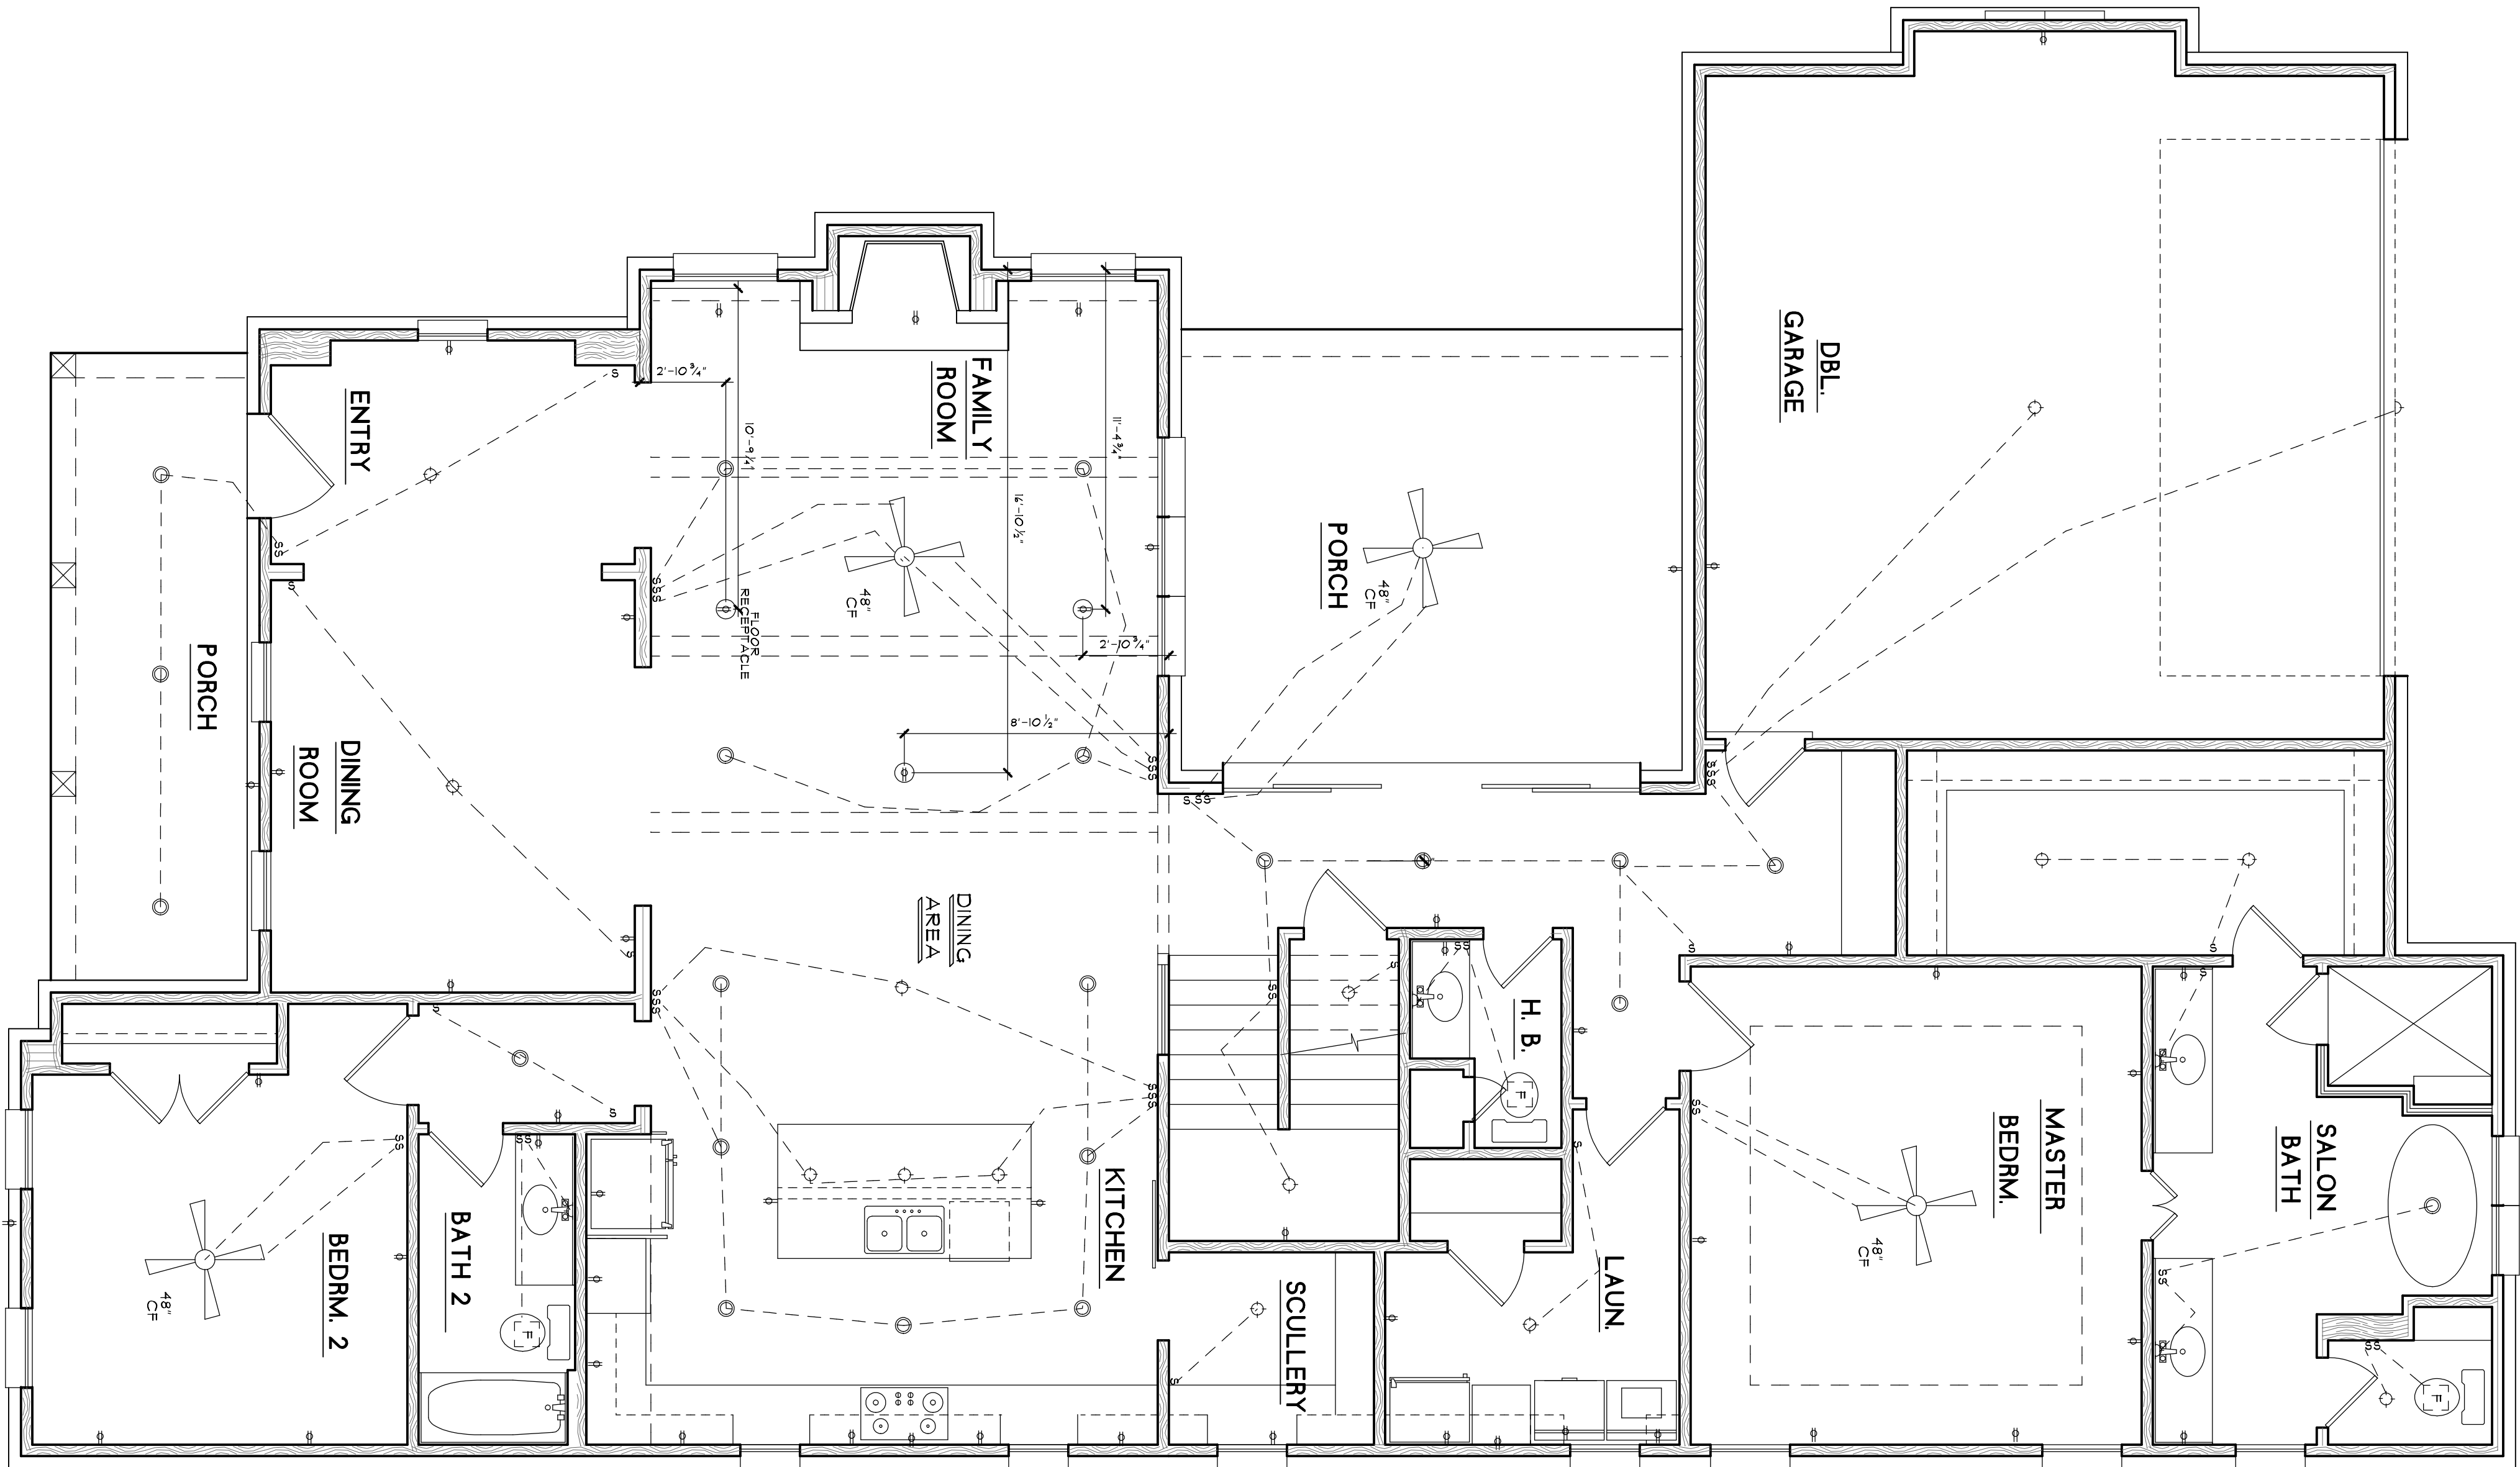

FIRST FLOOR ELECTRICAL PLAN
1/4" = 1'-0"

DRAWN :	CHECKED :
DATE : 8-03-2024	SCALE : AS NOTED
JOB NO. : PF#187	B805D RUCH
SHEET	4

AREAS:	
HTD DN	2238 SQ. FT.
HTD UP	391 SQ. FT.
TOTAL HTD	2629 SQ. FT.
PORCH	428 SQ. FT.
CAR & STOR.	575 SQ. FT.

AMERICAN INSTITUTE
OF BUILDING DESIGN


B | **A**
D | —

CLASSIC HOME DESIGNS

ED YENDREK AND ASSOCIATES
185 N MAIN ST. SUITE 101 38017
COLLIERVILLE, TENNESSEE
PHONE: 901-854-6900 FAX: 901-854-7170
WWW.CHDHOMED.COM

© COPYRIGHT 2024
CLASSIC HOME DESIGNS

CH

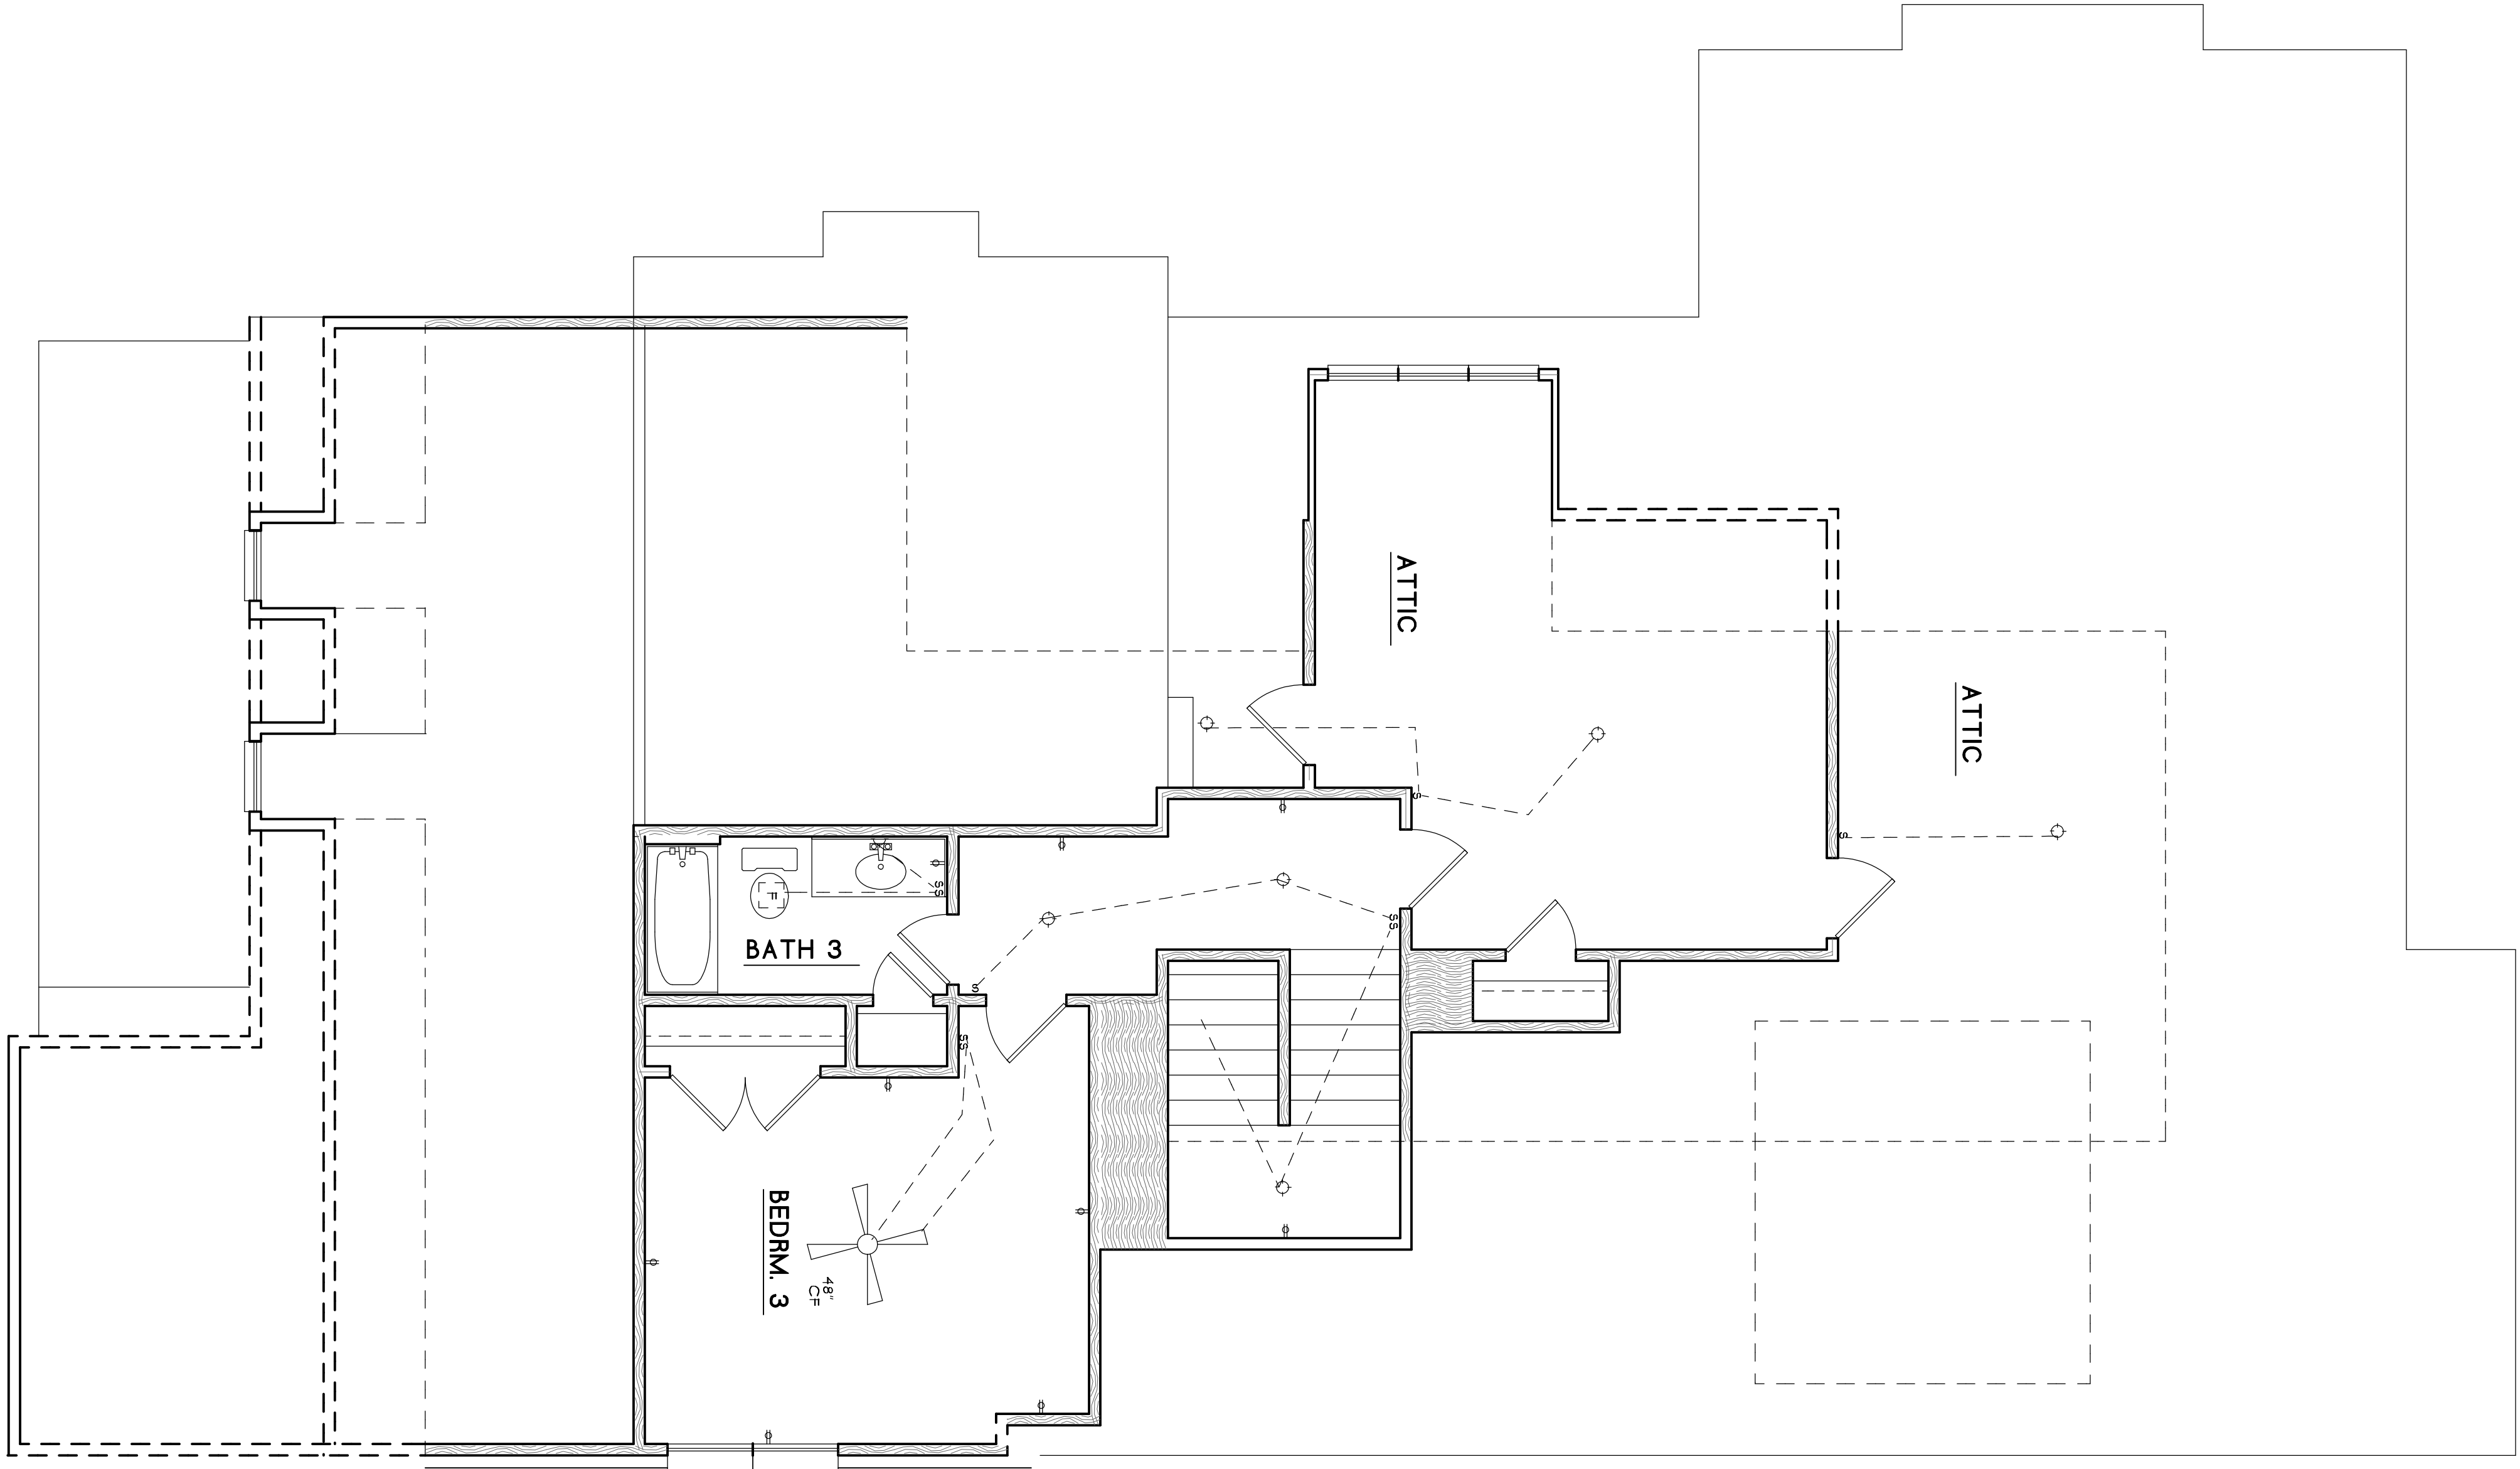

SECOND FLOOR ELECTRICAL PLAN
1/4"=1'-0"

AREAS:	
HTD DN	2238 SQ. FT.
HTD UP	391 SQ. FT.
TOTAL HTD	2629 SQ. FT.
PORCH	428 SQ. FT.
CAR & STOR.	515 SQ. FT.

DRAWN :	CHECKED :
---------	-----------

DATE :	8-03-2024
SCALE :	AS NOTED
JOB NO. :	B805D RUCH

SHEET	6
-------	---

AMERICAN INSTITUTE
OF BUILDING DESIGN

A

B

D

CLASSIC HOME DESIGNS

ED YENDREK AND ASSOCIATES
185 N MAIN ST. SUITE 101
COLLIERVILLE, TENNESSEE 38017
PHONE: 901-854-6900 FAX: 901-854-7170
WWW.CHDHOME.COM

© COPYRIGHT 2024
CLASSIC HOME DESIGNS

CHD