

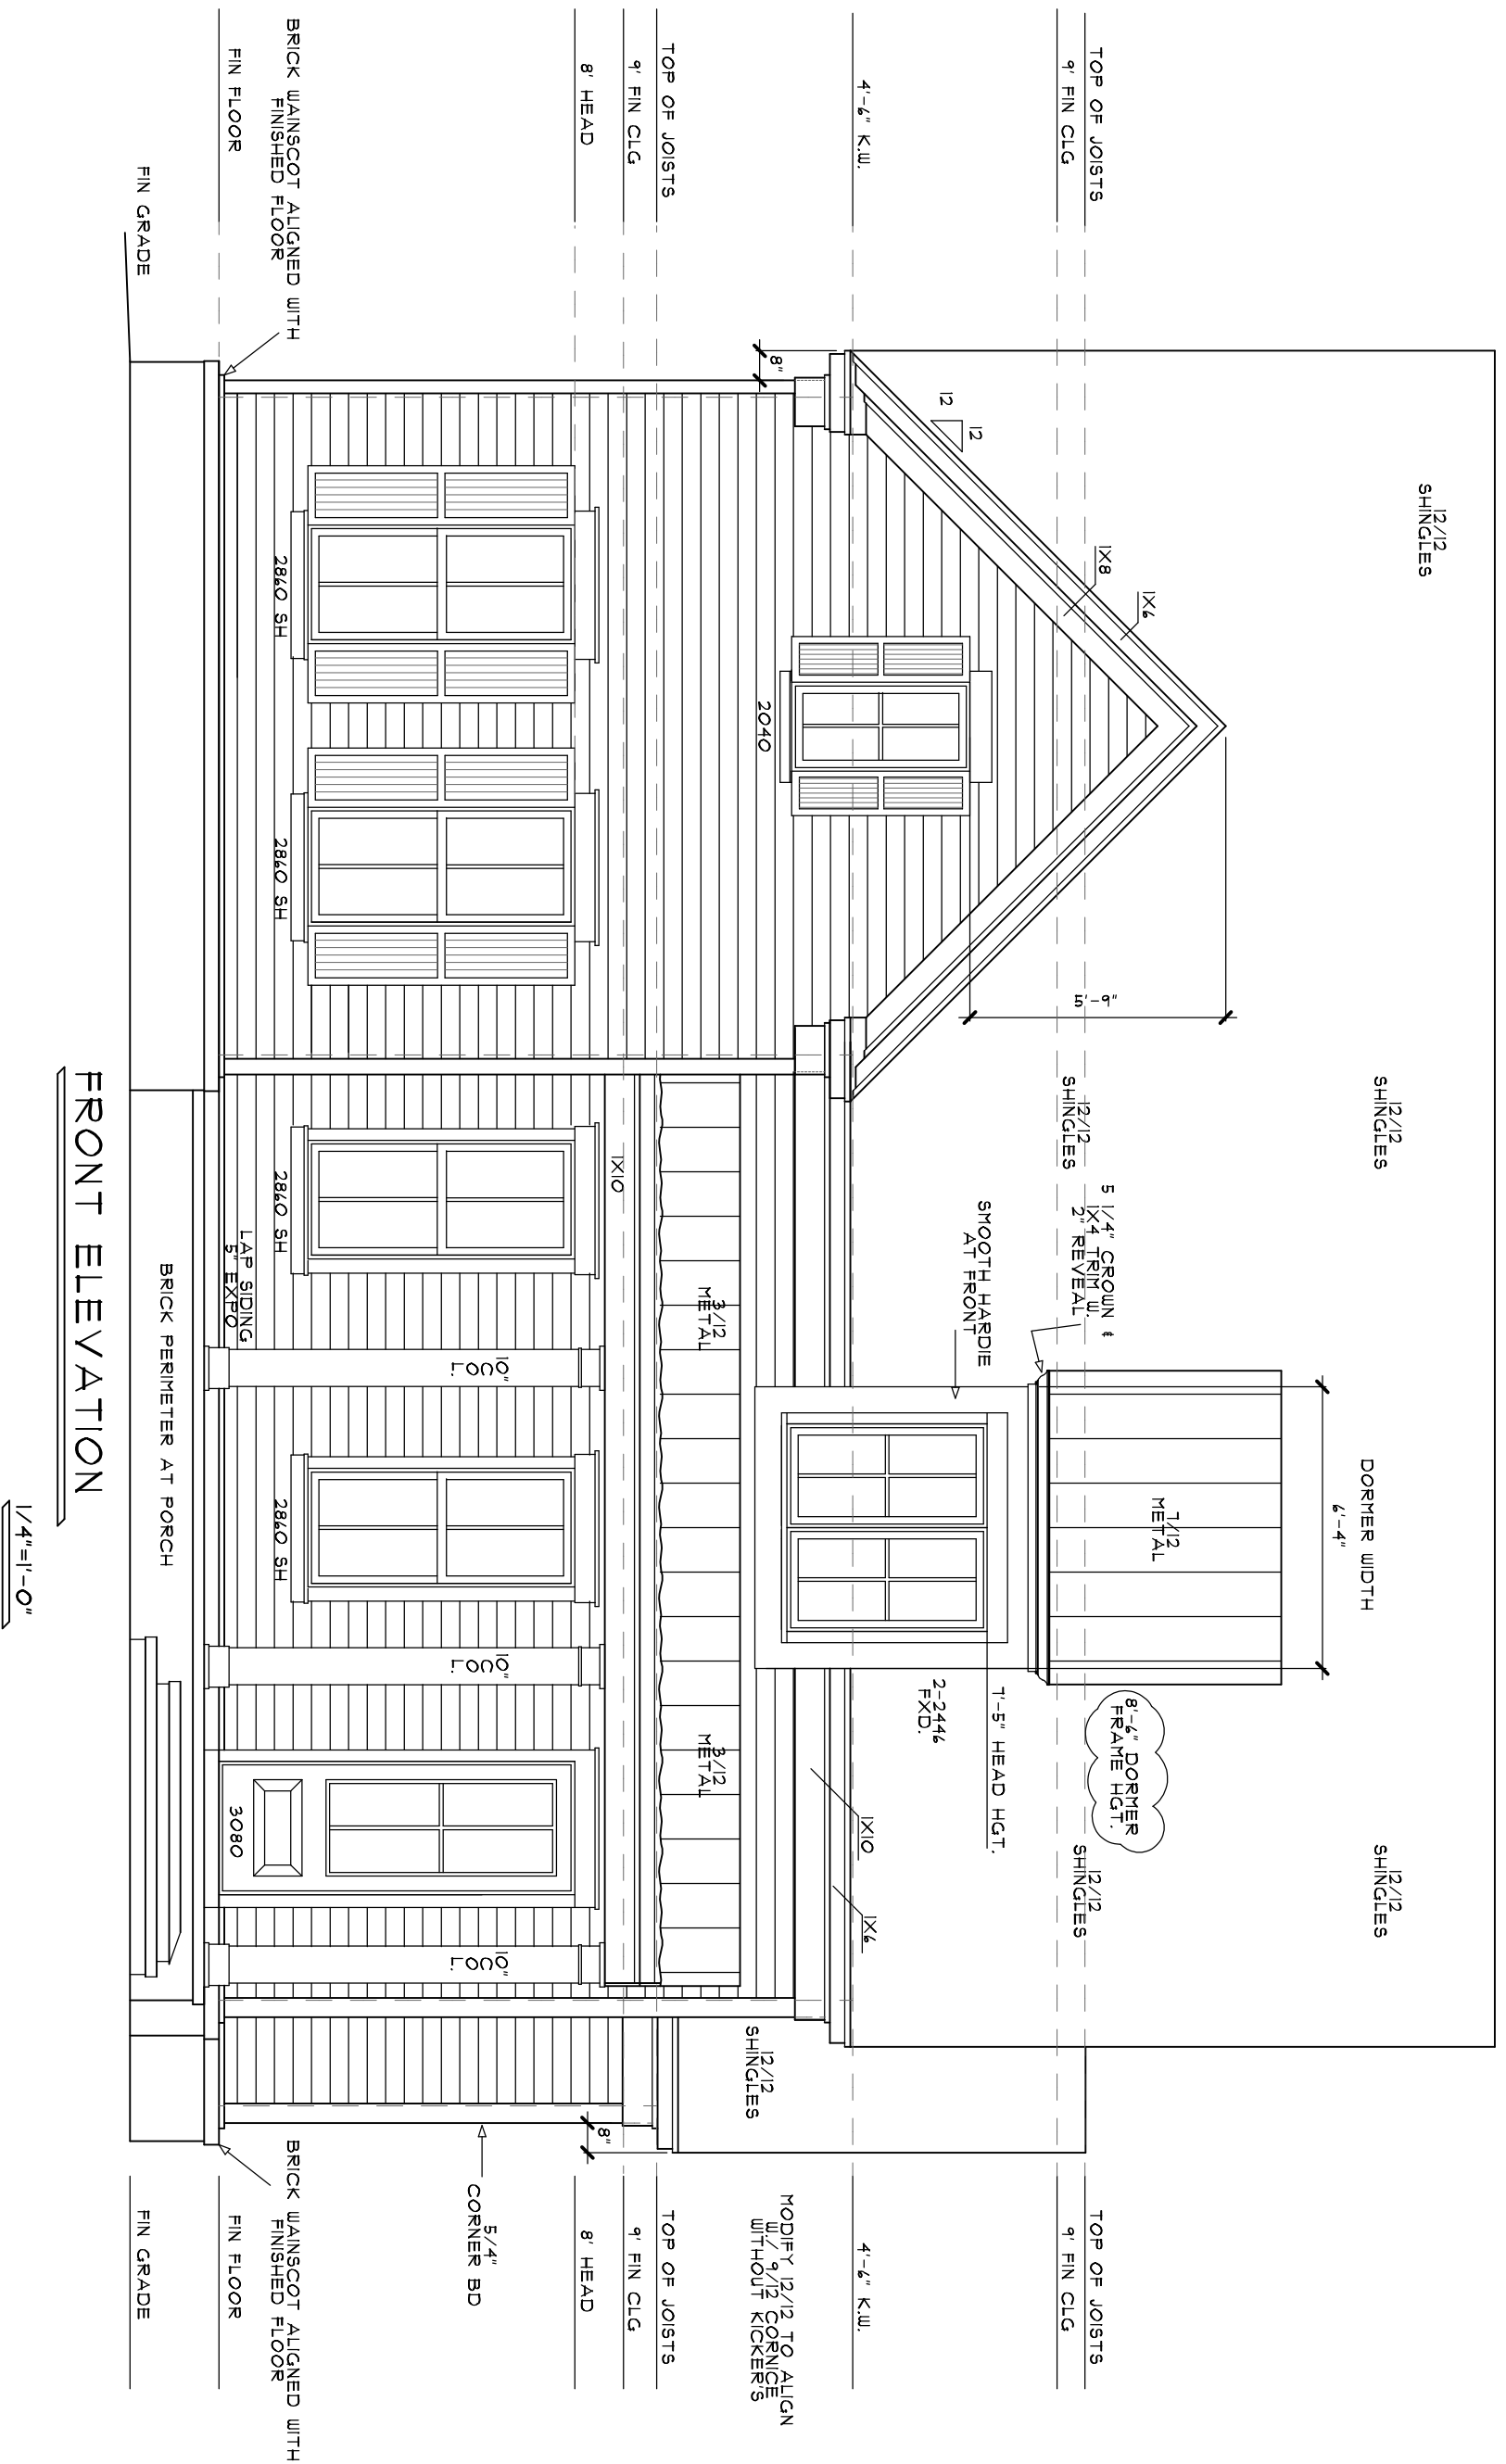


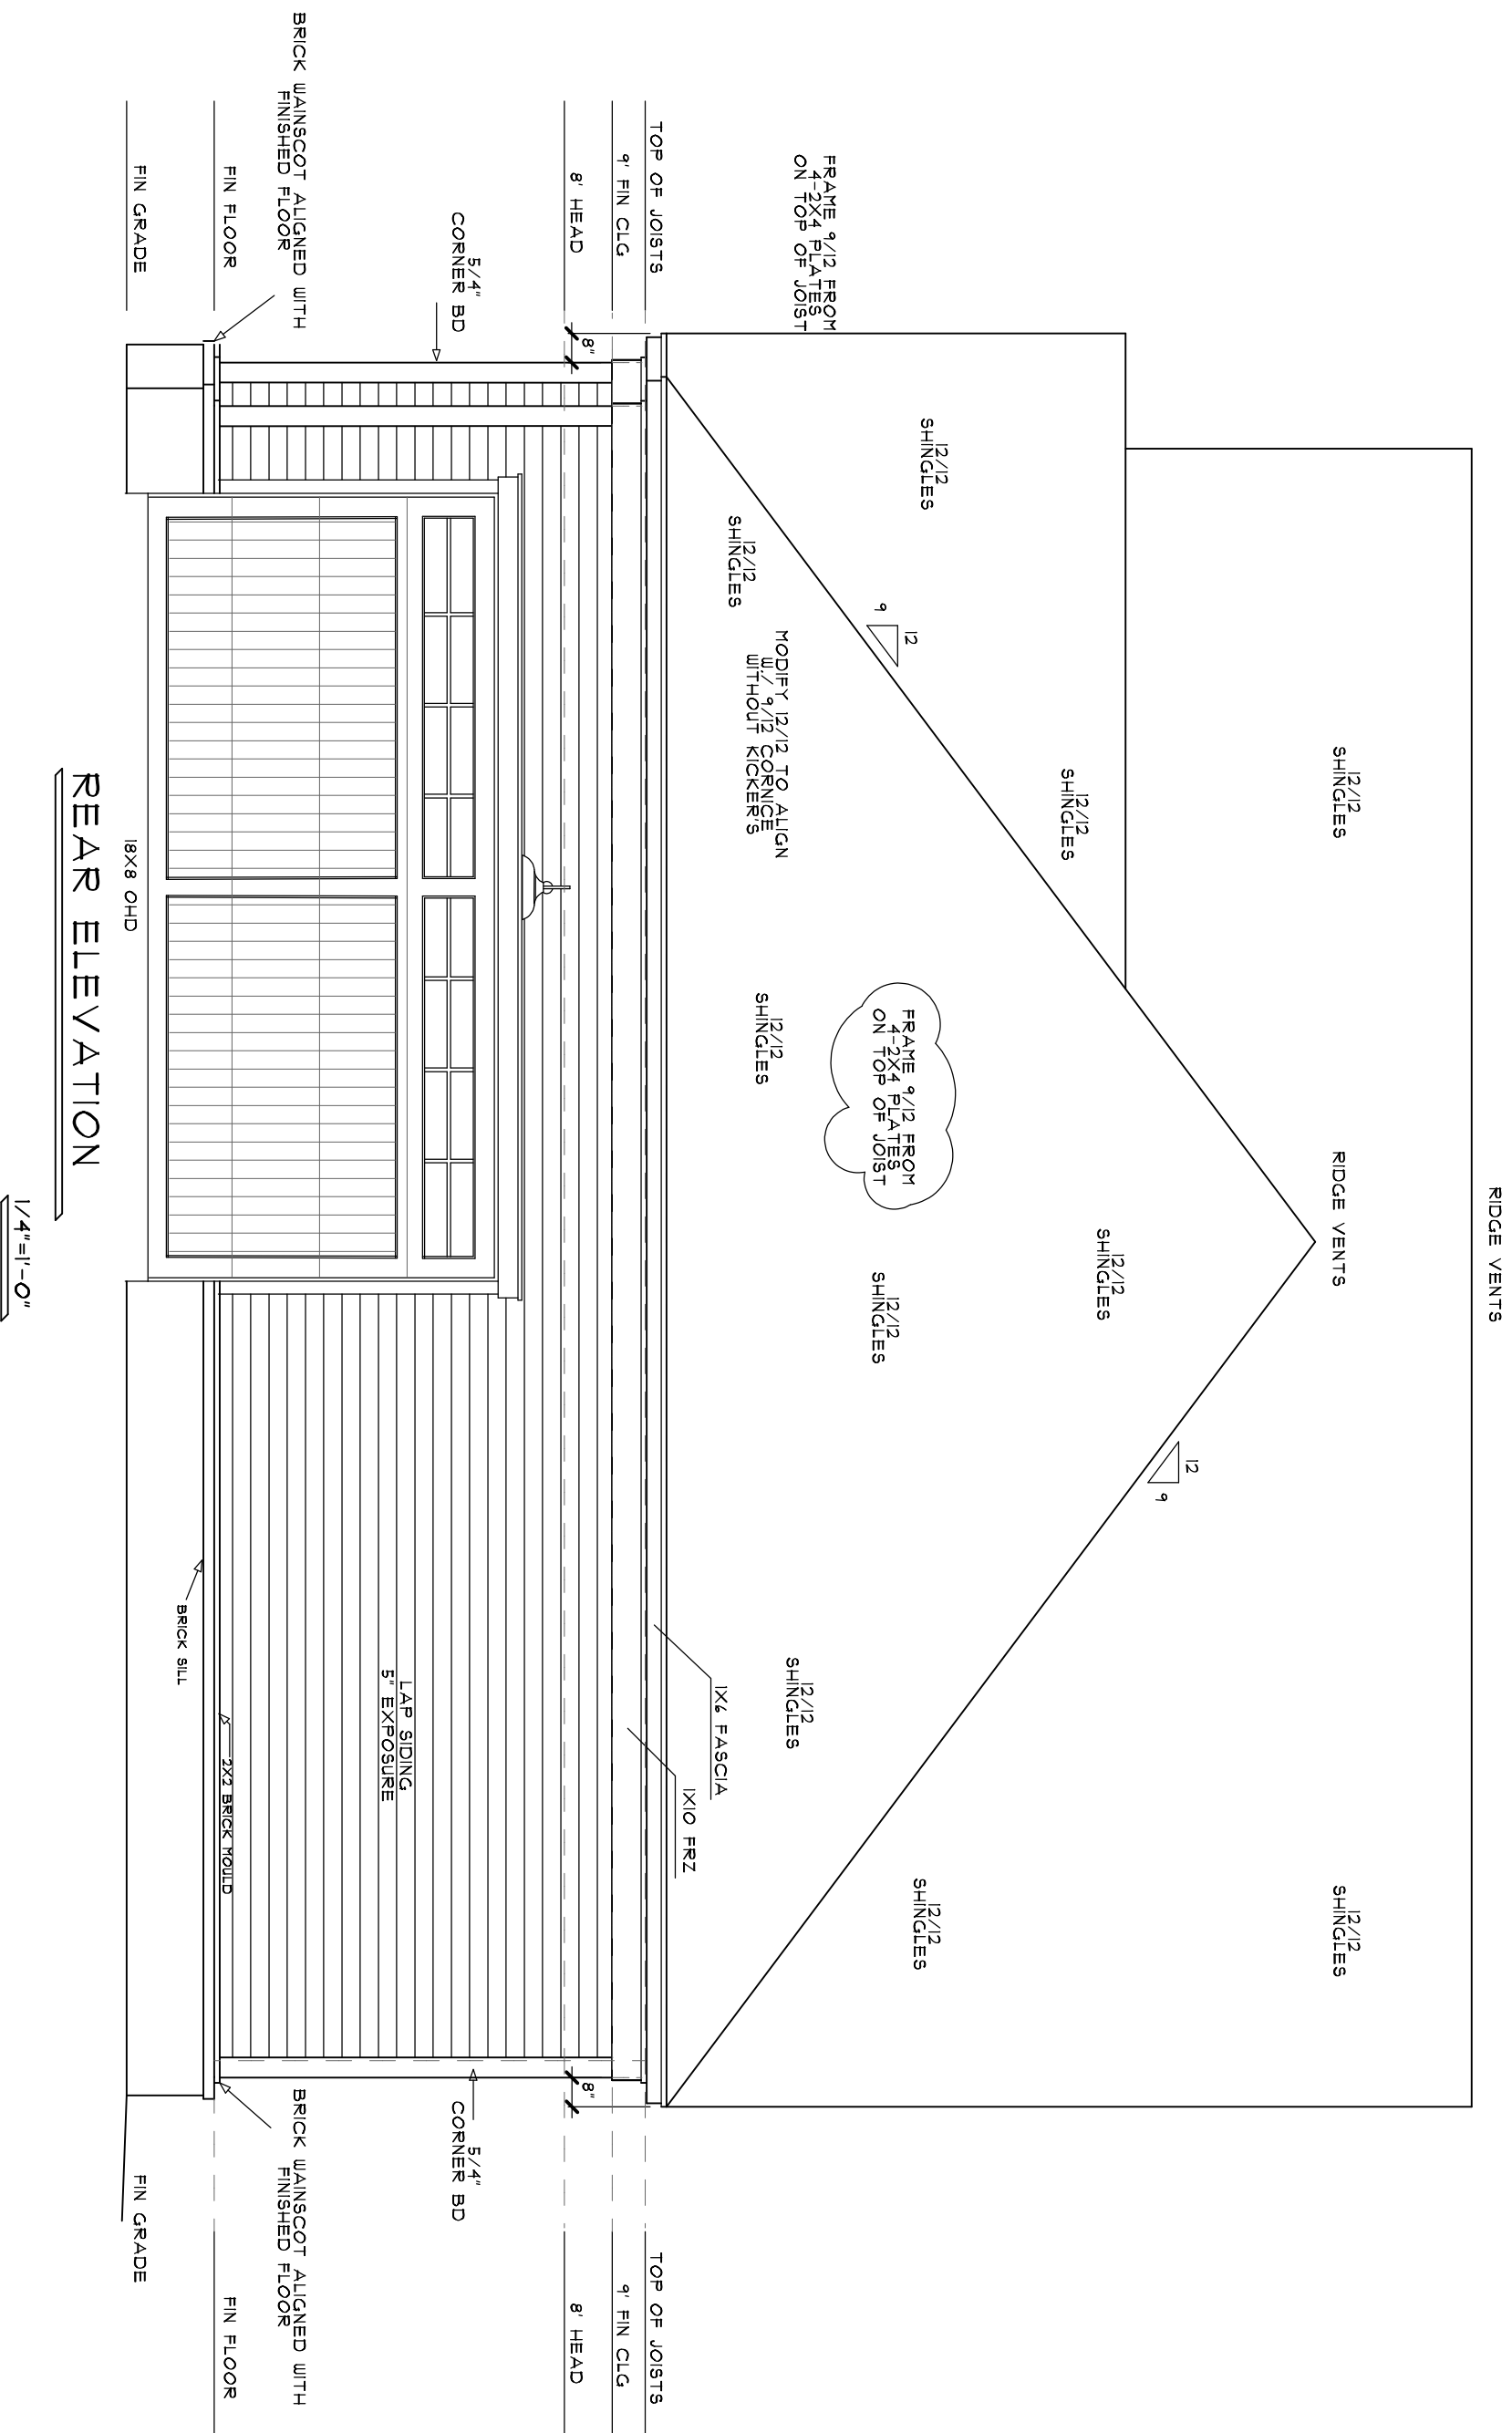


DRAWN :	CHECKED :
DATE :	7-19-2024
SCALE :	AS NOTED
JOB NO. :	B805B RUCH
SHEET :	PP#124-FLIP


AREAS:	
HTD DN	2195 SQ. FT.
TOTAL HTD	2195 SQ. FT.
PORCH	391 SQ. FT.
GAR & STOR.	801 SQ. FT.

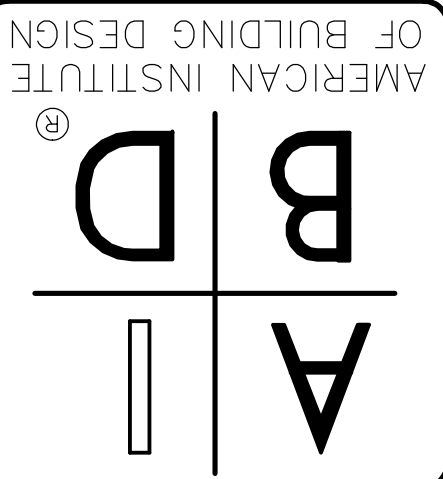

CLASSIC HOME DESIGNS

ED YENDREK AND ASSOCIATES
185 N MAIN ST. SUITE 101
COLLIERVILLE, TENNESSEE 38011
PHONE: 901-854-6900 FAX: 901-854-1100
WWW.CHDHOME.COM

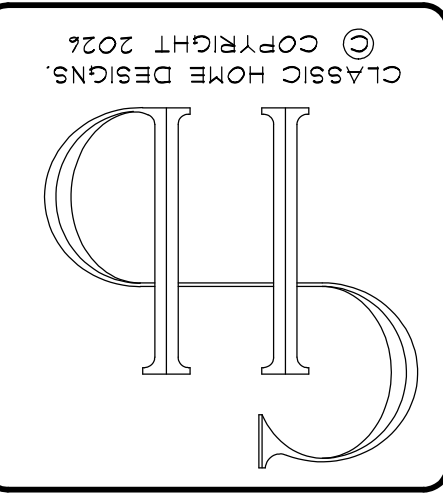

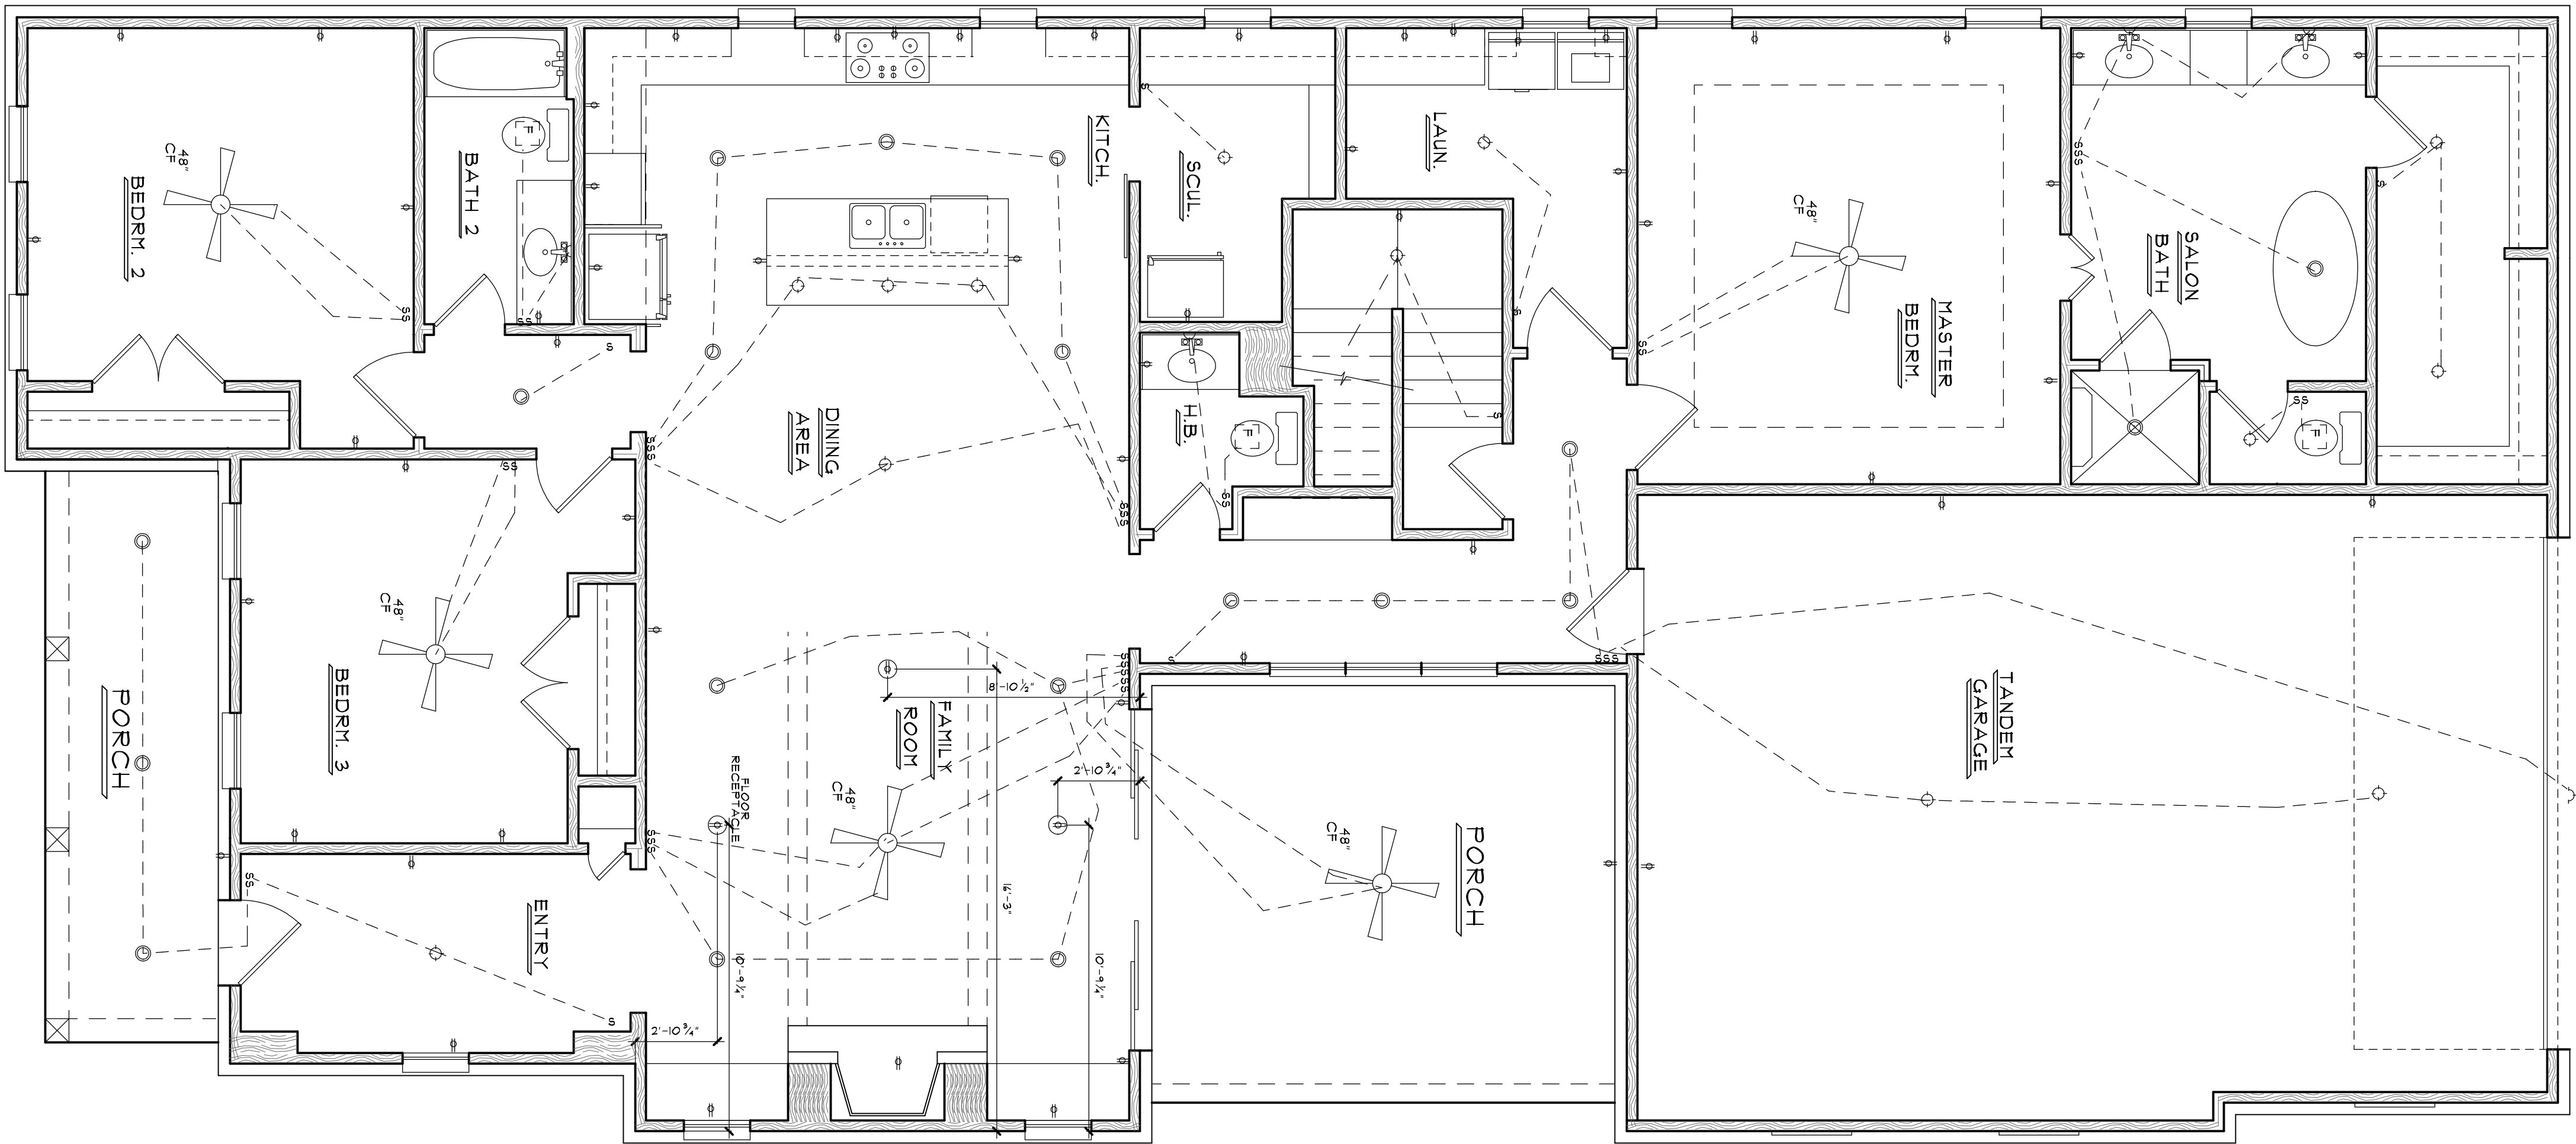

FIRST FLOOR ELECTRICAL PLAN
1/4"=1'-0"

DRAWN :	CHECKED :
DATE :	1-19-2024
SCALE :	AS NOTED
JOB NO. :	B805B RUCH
SHEET :	FP#124-FLIP

AREAS:	
HTD DN	2195 SQ. FT.
TOTAL HTD	2195 SQ. FT.
PORCH	391 SQ. FT.
GAR & STOR.	801 SQ. FT.

AMERICAN INSTITUTE
OF BUILDING DESIGN
®

B / **A**
D / —

CLASSIC HOME DESIGNS

ED YENDREK AND ASSOCIATES
185 N MAIN ST., SUITE 101
COLLIERVILLE, TENNESSEE 38011
PHONE: 901-854-6900 FAX: 901-854-7170
WWW.CHDHOME.COM

CLASSIC HOME DESIGNS
© COPYRIGHT 2024

CH